




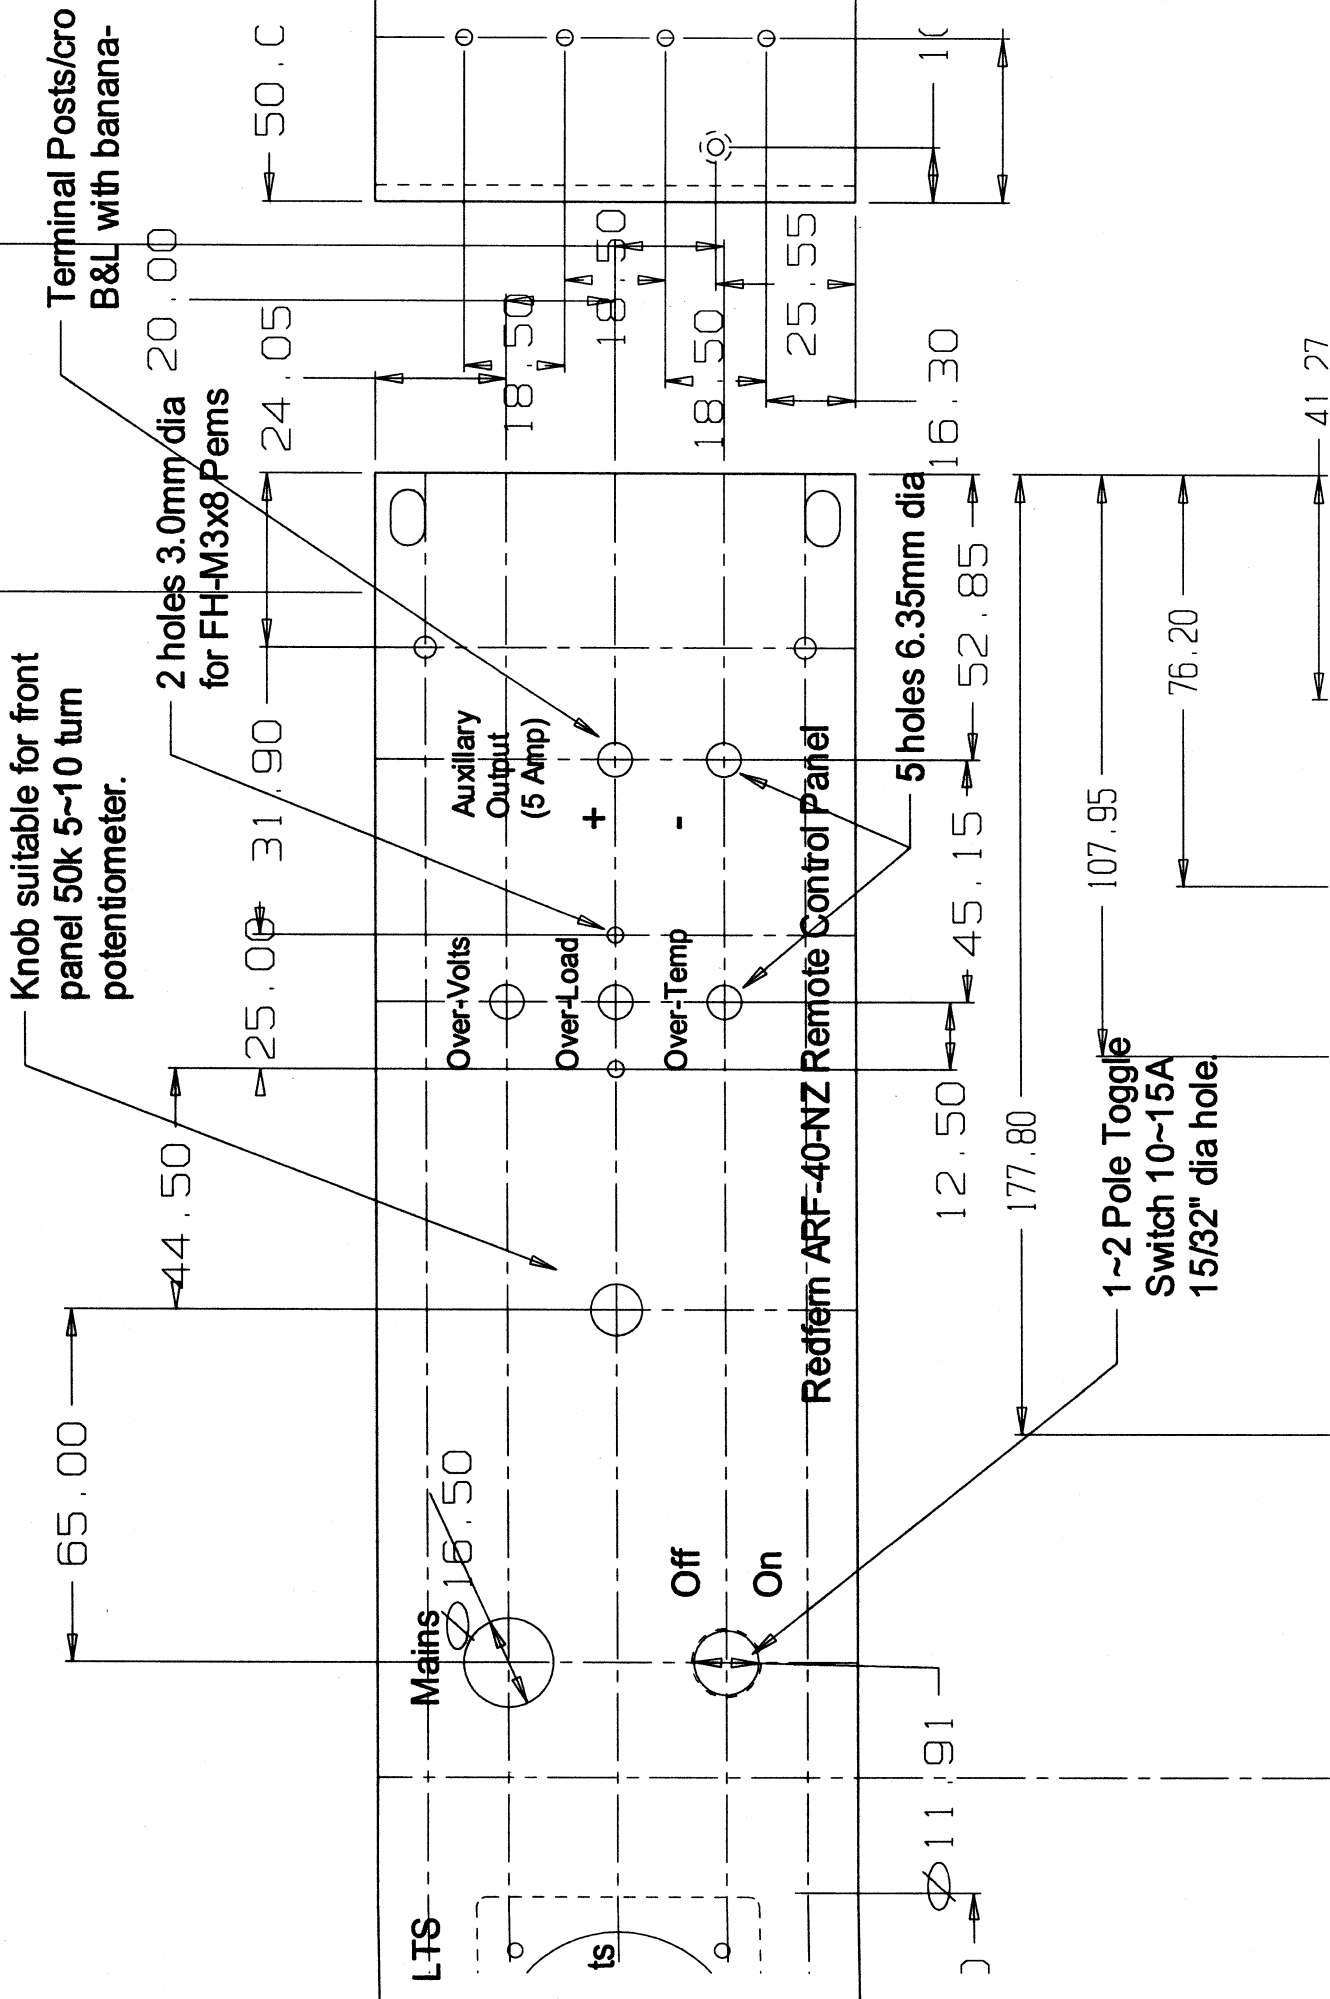

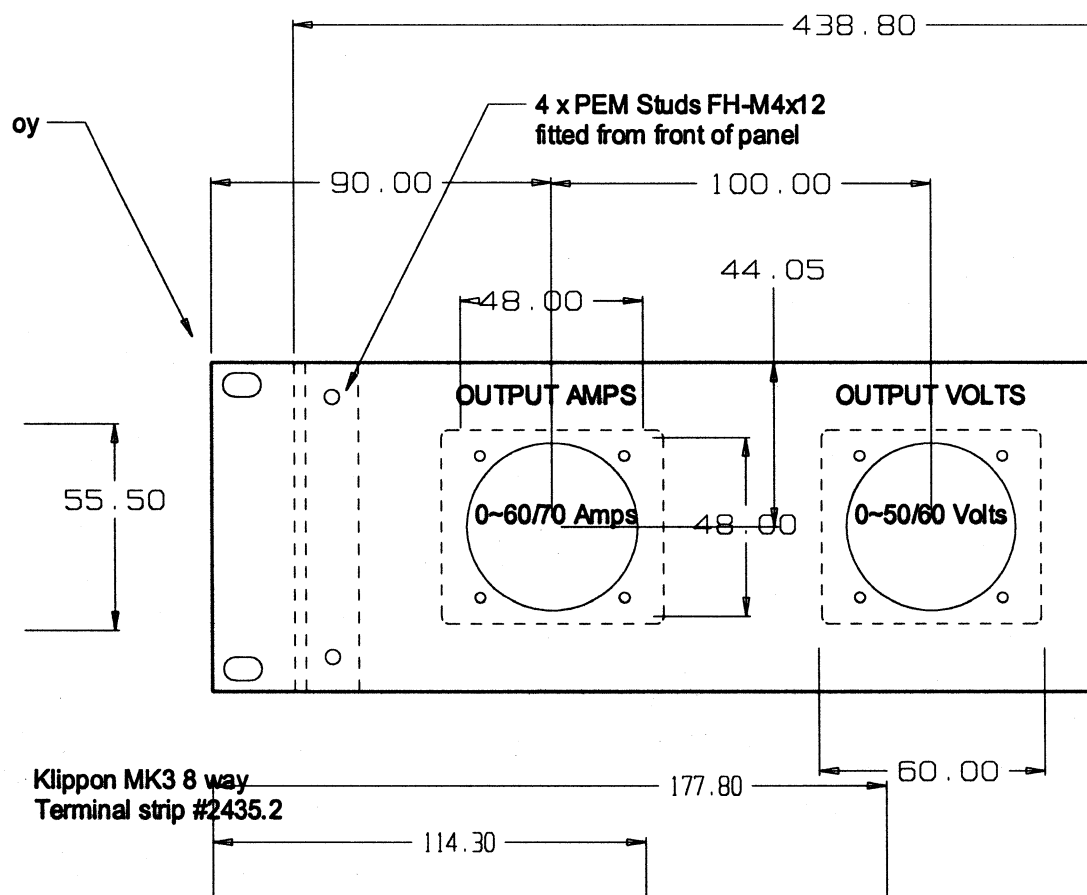

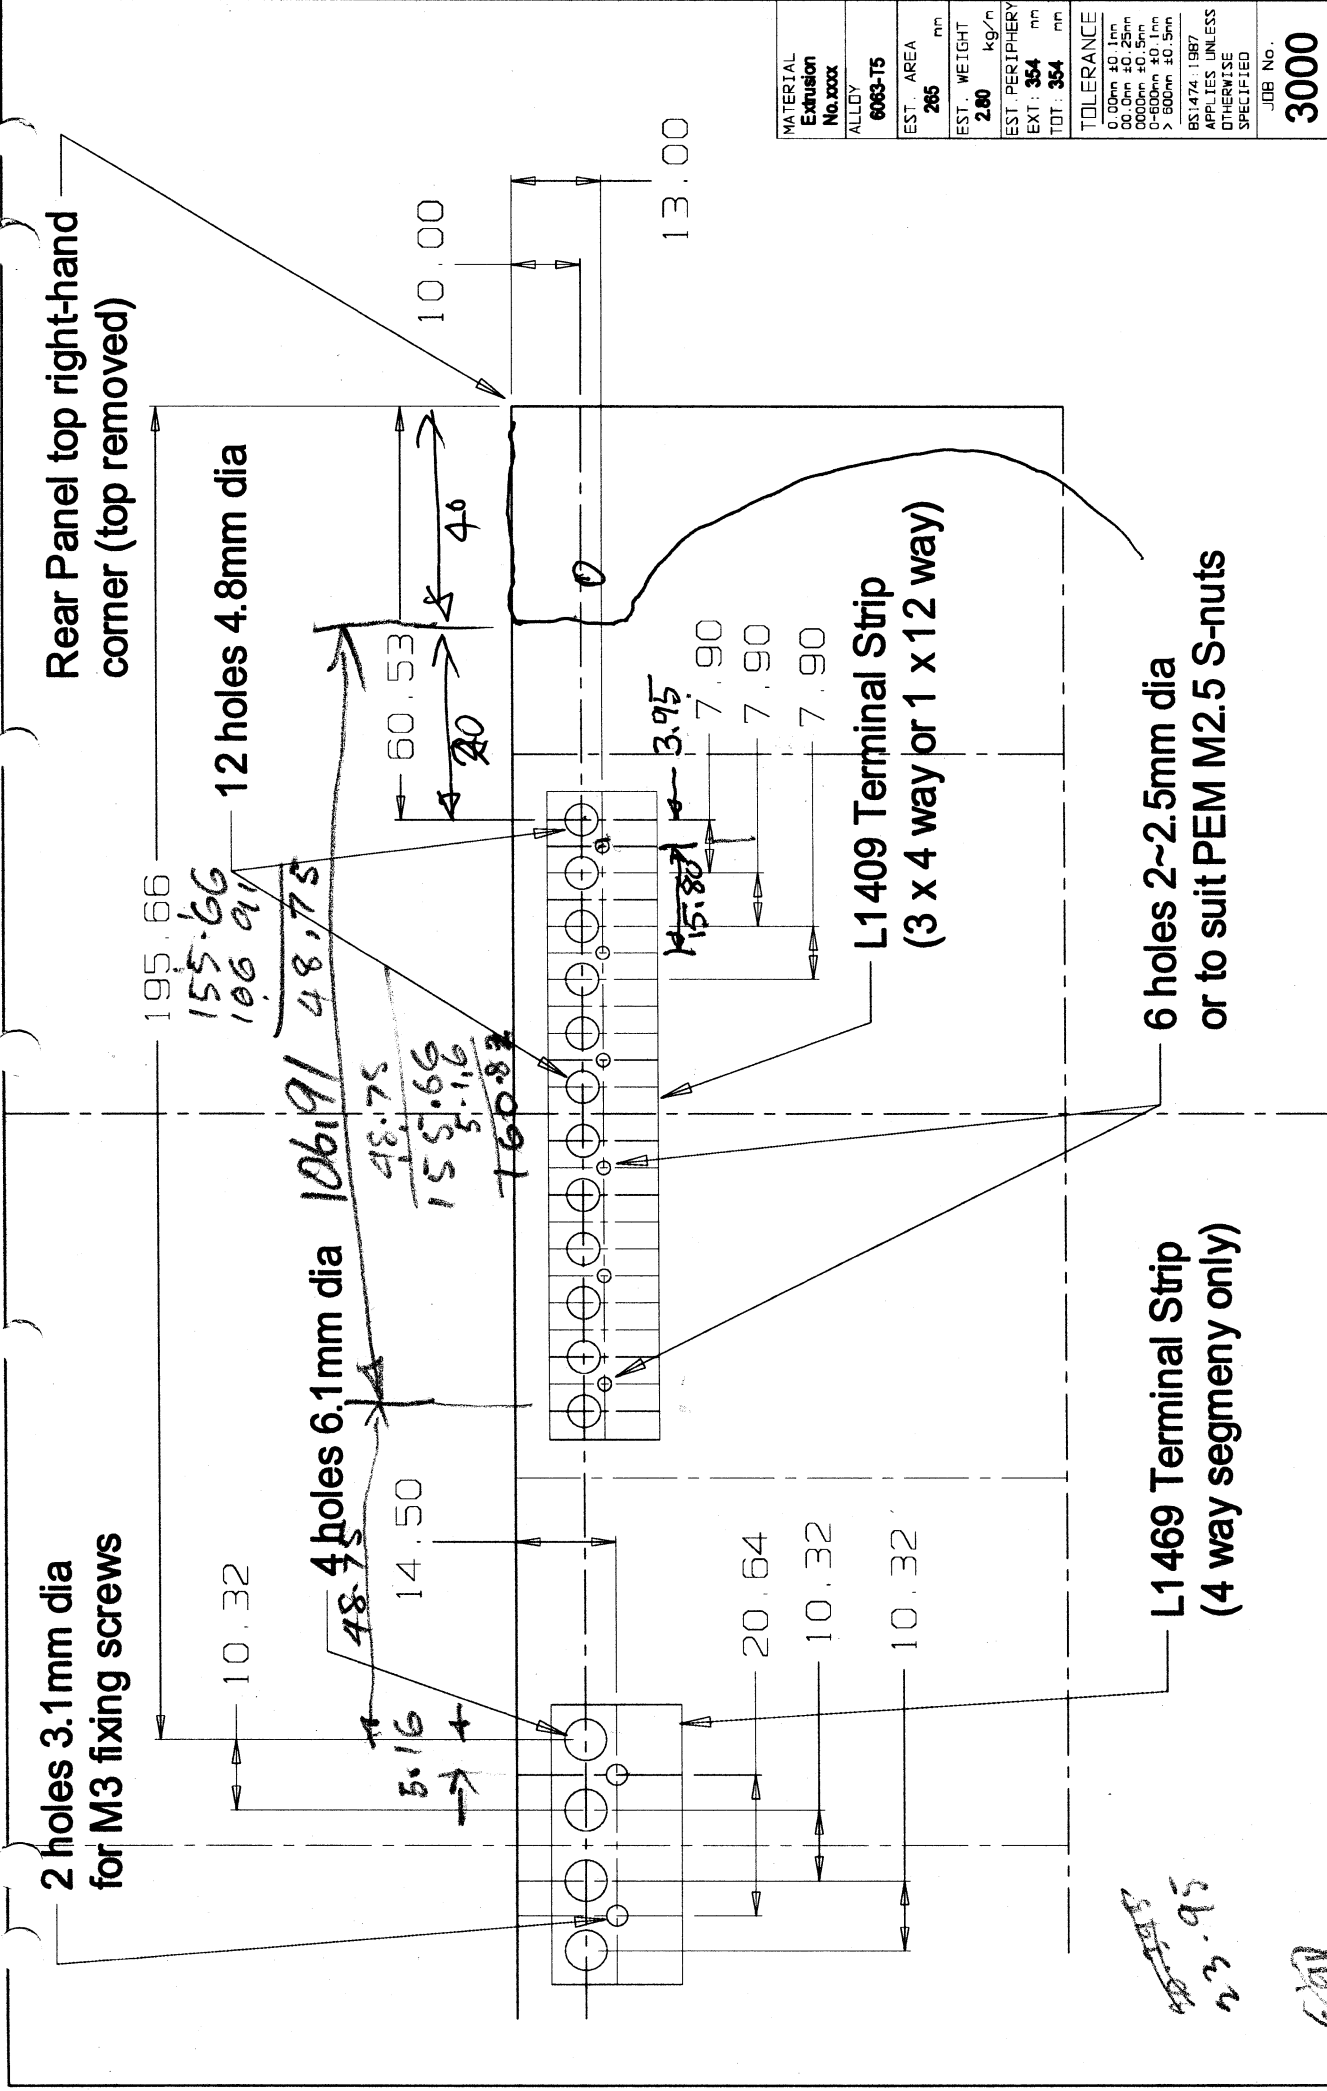


MATERIAL	Extrusion	No. xxxxx
ALLOY	6063-T5	
EST. AREA	285	mm
EST. WEIGHT	2.80	kg/m
EST. PERIPHERY	EXT: 354	mm
TOT: 354		mm
TOLERANCE	0.00mm ±0.1mm 00.0mm ±0.25mm 0000mm ±0.5mm 0-600mm ±0.1mm > 600mm ±0.5mm BS: 1474: 1987 APPLIES UNLESS OTHERWISE SPECIFIED	
JOB No.	3000	

CASA Modular Systems		CUSTOMER : CASA Modular Systems	SIZE	DRAWING Reference No	ISSUE
		DESCRIPTION : Back-Panel Drilling for Redfern PSU	A4	REDFERN-BPA	
DRAWN : AWD	DATE : 28/08/10	APPROVED : ?	DWG. SCALE : 1:1		
COPYRIGHT : CASA Modular Systems ALL RIGHTS RESERVED					


CASA Modular Systems	P.O. BOX 38-828, WELLINGTON, NEW ZEALAND TELEPHONE : (64-4) 5687 277 FACSIMILE : (64-4) 5685 161				
----------------------	--	--	--	--	--


REDFERN-BPA

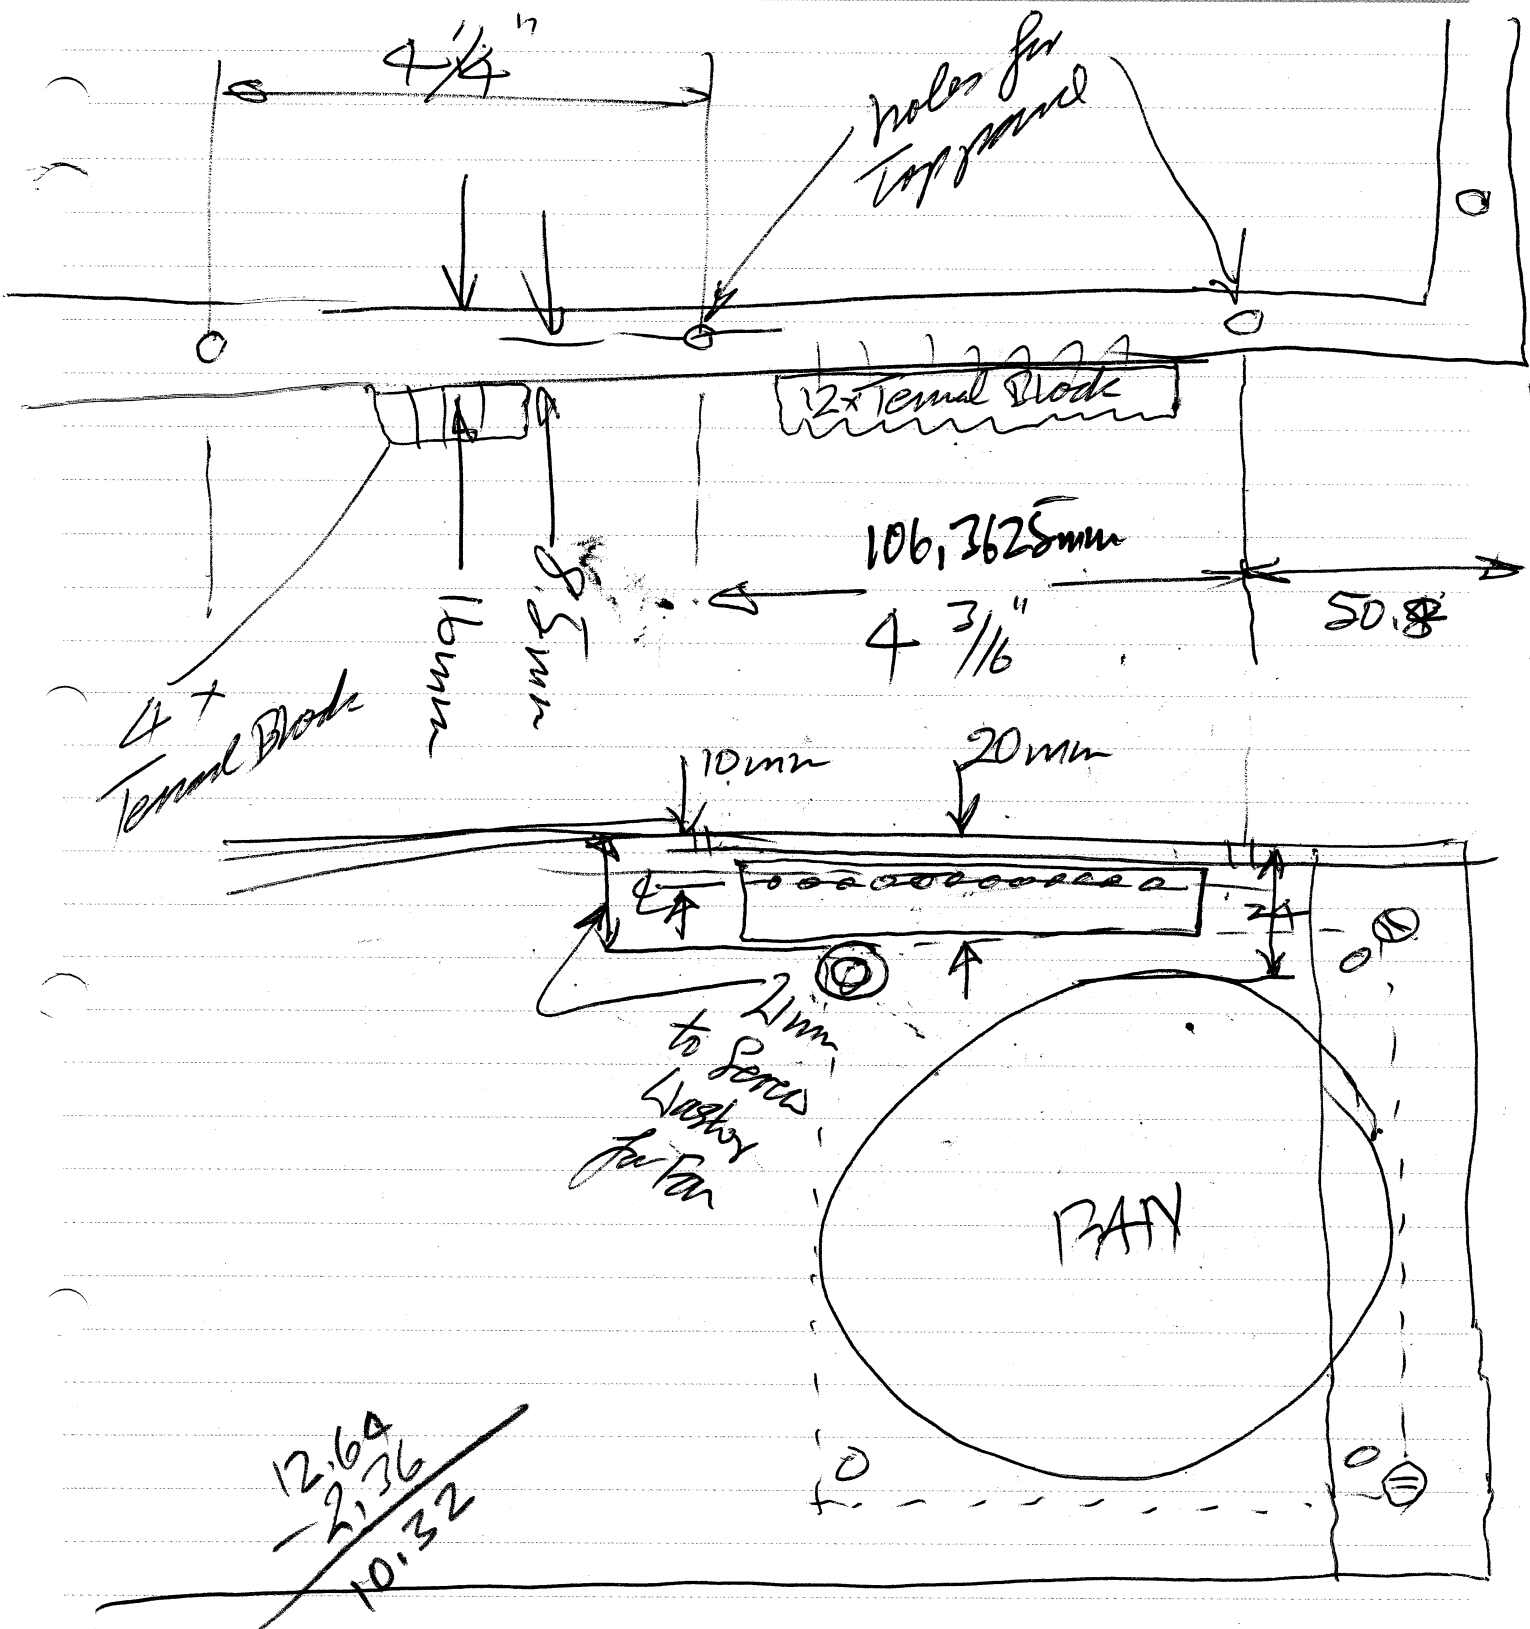

26/8/10


Redfern PSU Rear
Panel Connections

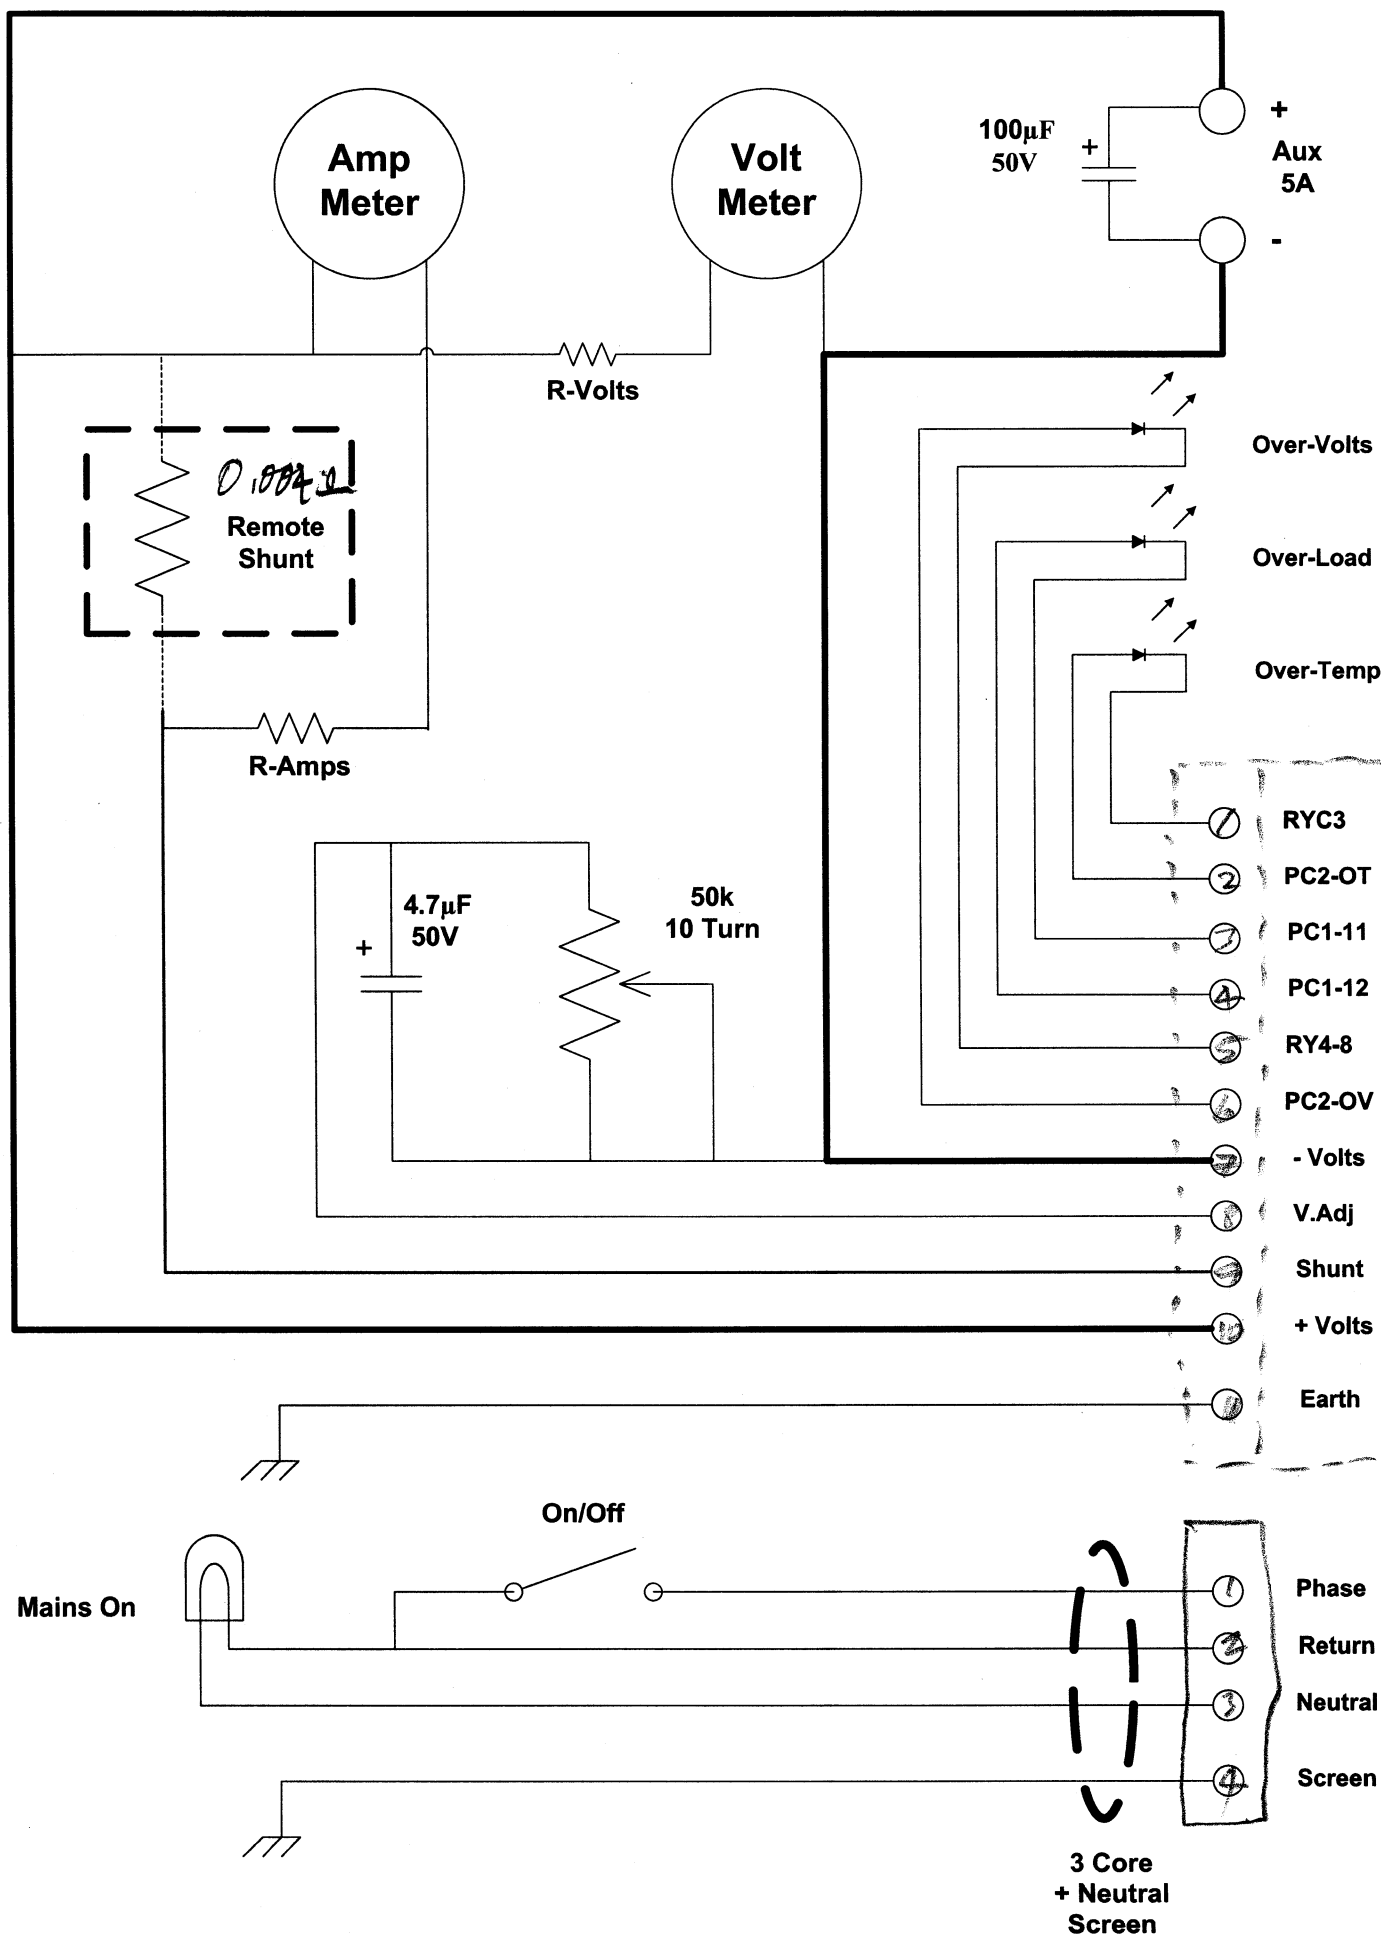**Remote Control Schematic for Redfern ASR40**

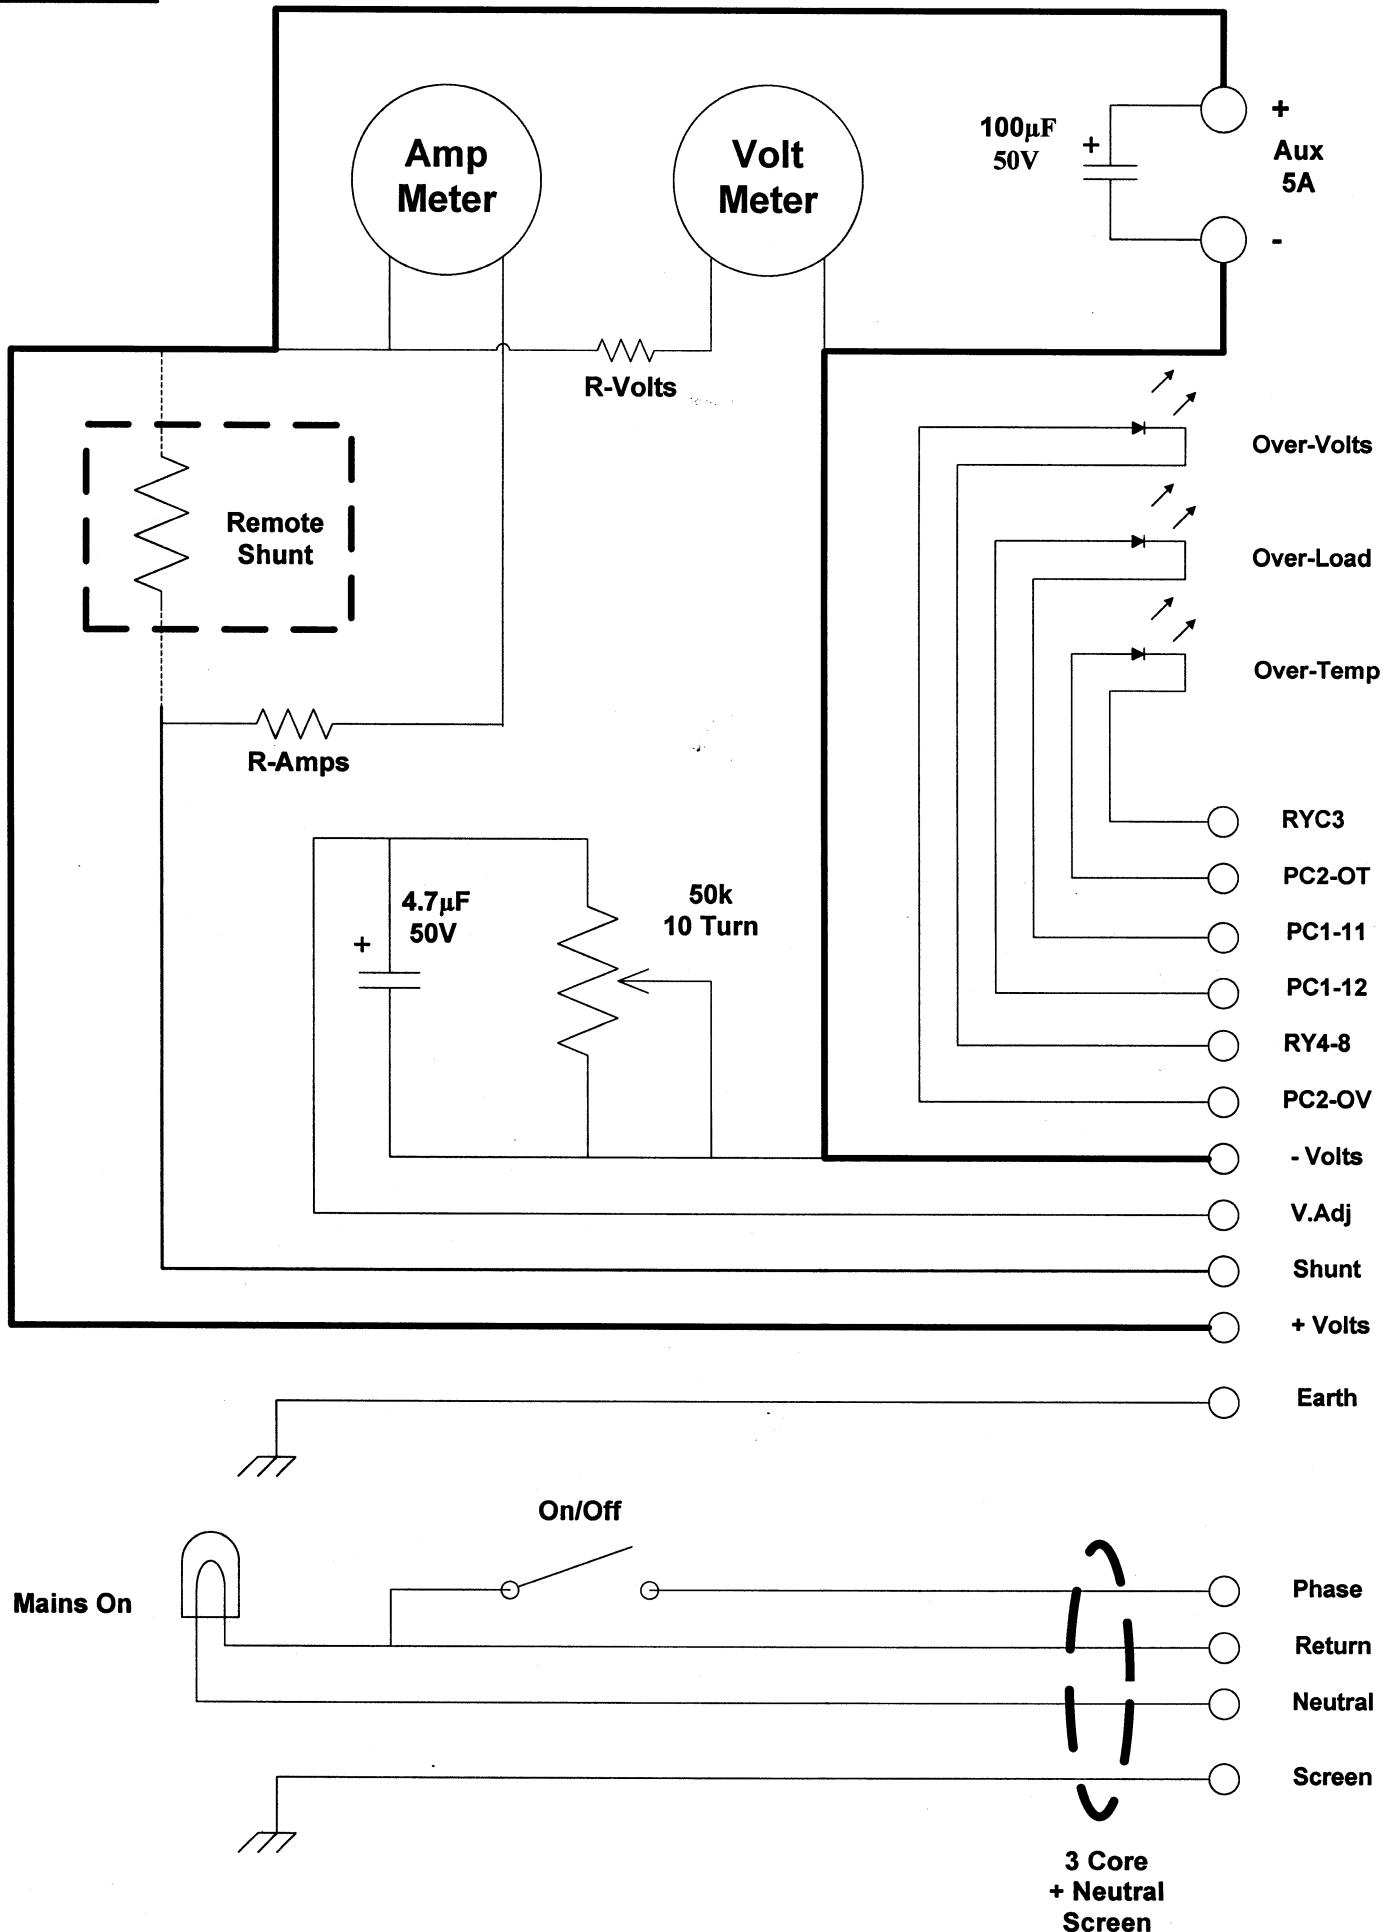

**Remote Control Schematic for
Redfern ASR40**

Sunday, August 15, 2010 19:44:29

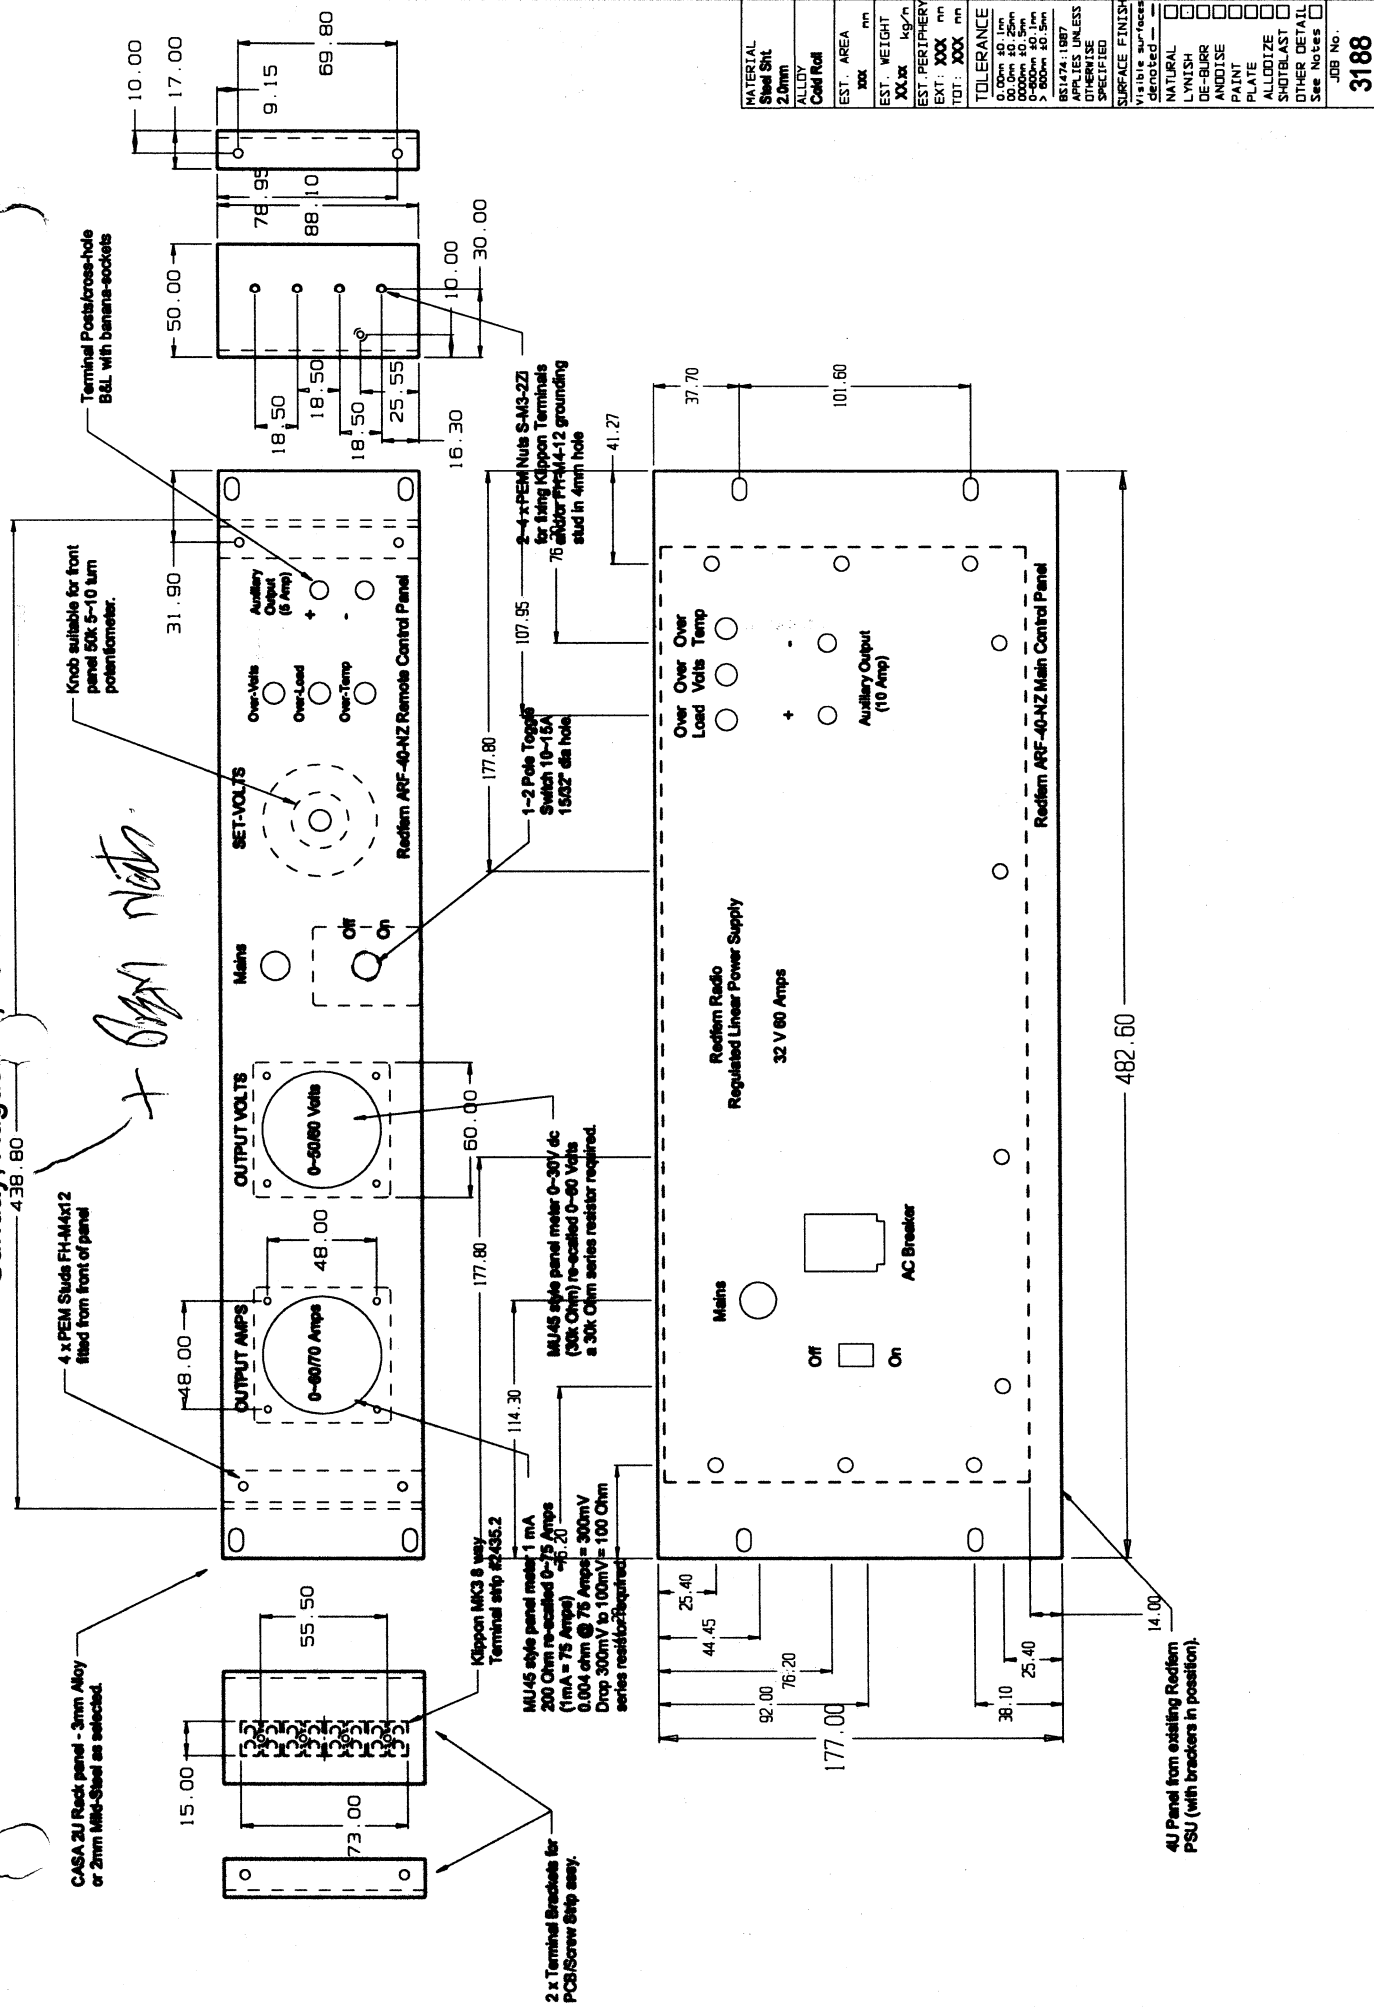[illegible]

CASA Part Number for BLANK = "RP-2U-MS20(BLANK)"
CASA Part Number for BLANK = "RP-4U-MS30(BLANK)"

CUSTOMER : CASA Modular Systems


SIZE

Redfem-PNL

ence No. | ISSUE

© 1997 BY CERN. ALL RIGHTS RESERVED



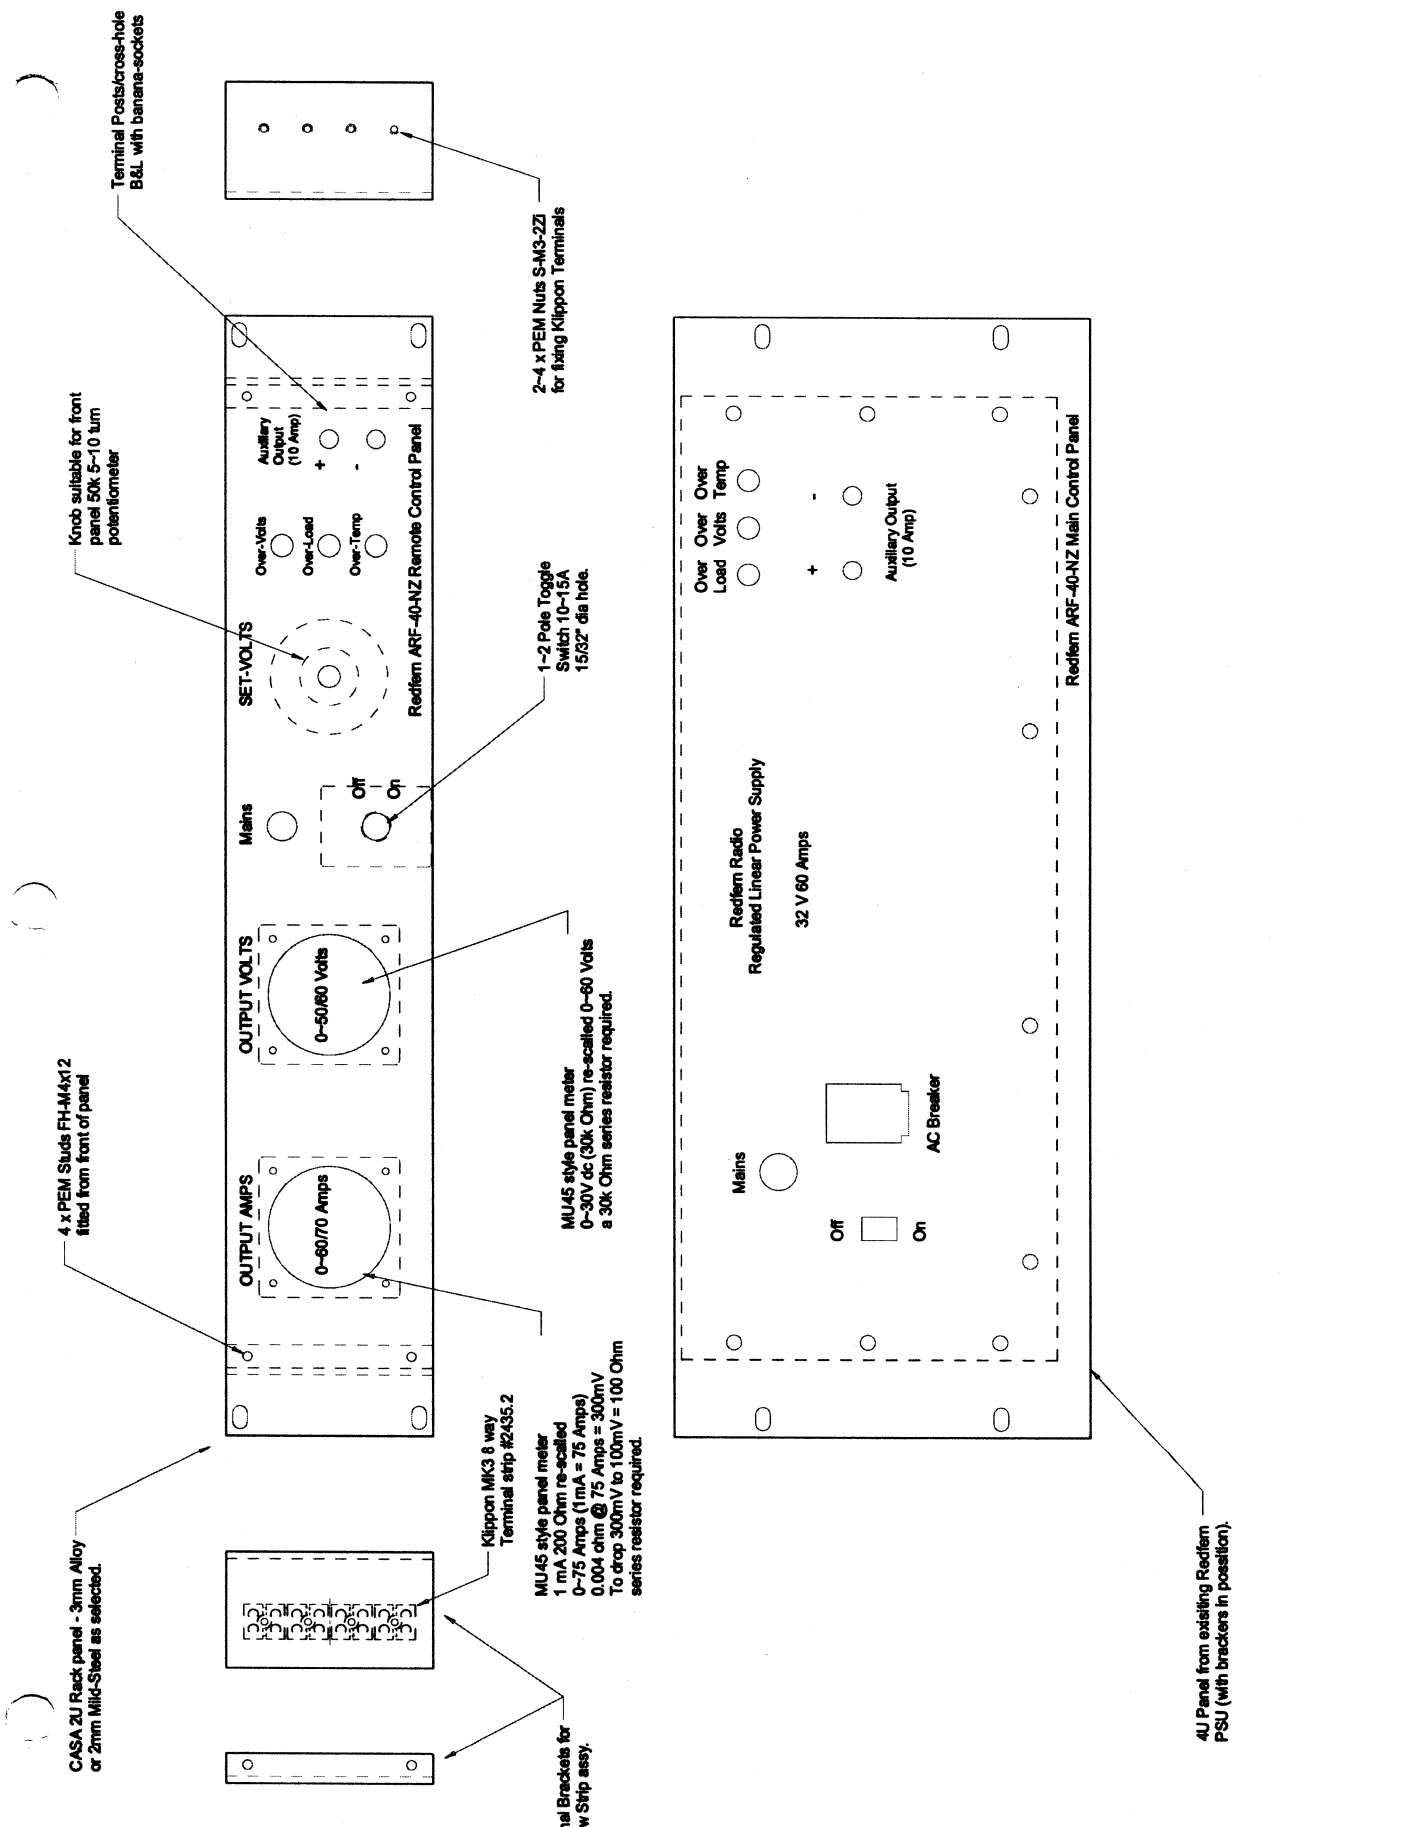


MATERIAL	Steel Sht	2.0mm
ALLOY		
Cold Roll		
EST. AREA	mm	
xxx		
EST. WEIGHT	kg/m	
xxx		
EST. PERIPHERY	mm	
EXT : xxx		
TOT : xxx		
TOLERANCE		
0.00mm ±0.1mm		
0.00mm ±0.25mm		
0.00mm ±0.5mm		
0.00mm ±0.75mm		
> 0.00mm ±0.5mm		
BS1474 1987		
APPLIES UNLESS OTHERWISE SPECIFIED		
SURFACE FINISH		
Visible surfaces		
denoted by		
NATURAL		
DE-BURR		
ANODISE		
PAINT		
ALLODIZE		
SHOTBLAST		
OTHER DETAIL		
See Notes		
JOB No.		


3188

CUSTOMER	CASA Modular Systems	SIZE	A4	Redfern-PNL	ISSUE	A
DESCRIPTION	Control Panels for Redfern 60 Amp RPS	DWG. SCALE				
DRAWN	DATE	APPROVED				
Redfern	1987	1987				

CASA Part Number for BLANK = "RP-2U-MS20K(BLANK)"
CASA Part Number for BLANK = "RP-4U-MS30K(BLANK)"

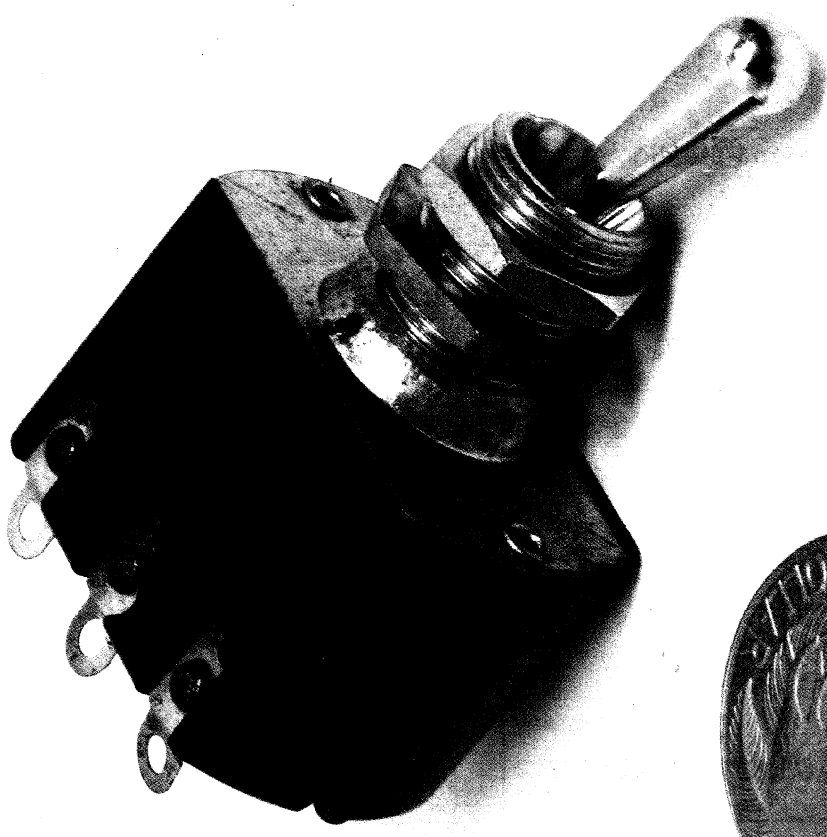

CASA 2U Rack panel - 3mm Alloy or 2mm Mild-Steel as selected.

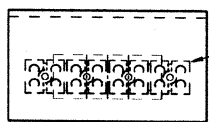


Klippon MK3 8 way Terminal strip #2435.2




2 x Terminal Brackets for PCB/Screw Strip assy.



Knob suitable for front panel 50k 5-10 turn potentiometer

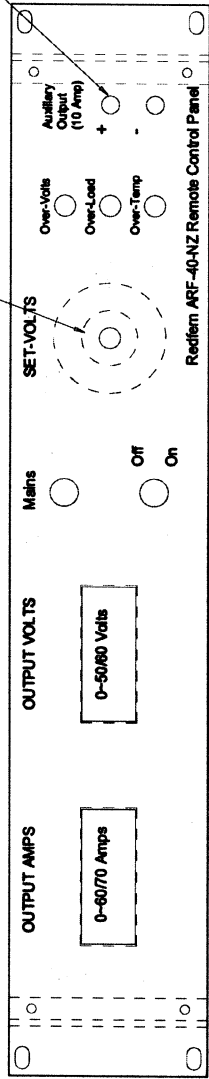

  Terminal Posts/cross-hole B&L with banana-sockets

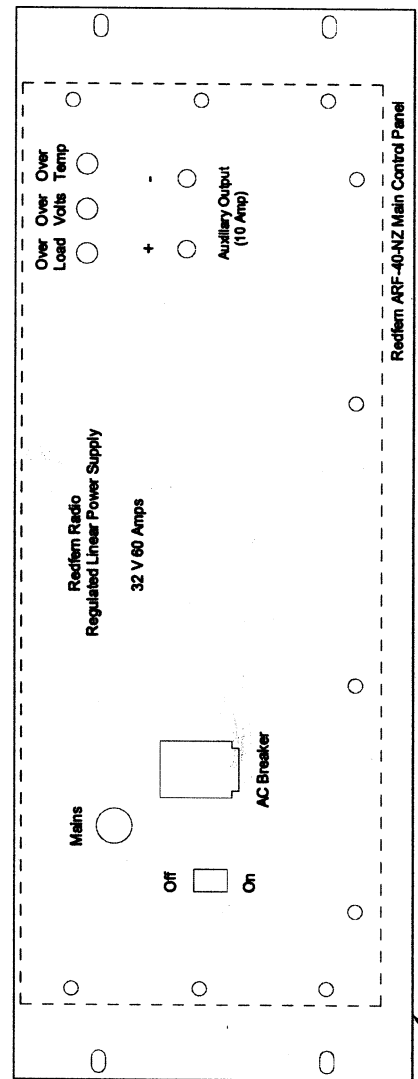

4U Panel from existing Redtem PSU (with brackets in position).

MATERIAL	Steel Sht
2.0mm	
ALLOY	
Cold Roll	
EST. AREA	mm
xxx	mm
EST. WEIGHT	kg/c
xxx	mm
EST PERIPHERY	mm
EXT: xxx	mm
TOT: xxx	mm
TOLERANCE	
0.0mm to 0.2mm	
0.2mm to 0.5mm	
0.5mm to 1.0mm	
1.0mm to 2.0mm	
2.0mm to 3.0mm	
3.0mm to 4.0mm	
99.0mm to 100.0mm	

CASA Part Number for BLANK = "RP-2U-MS20V BLANK"
CASA Part Number for BLANK = "RP-4U-MS30V BLANK"

CASA

Modular Systems

TEL: 06 387 9611

TEL: 06 387 9612

FACSIMILE: (06 4) 5885 161

E-MAIL: casaelectrix-gen.nz

CUSTOMER: CASA Modular Systems

DESCRIPTION: Control Panels for Redtem 60 Amp RPS

DATE: 13/08/10

DRAWN: AWD

APPROVED: 7

SIZE: A4

DWG. SCALE: 1:1

ISSUE: A

Redtem-PNL

Redtem

ALL RIGHTS RESERVED